


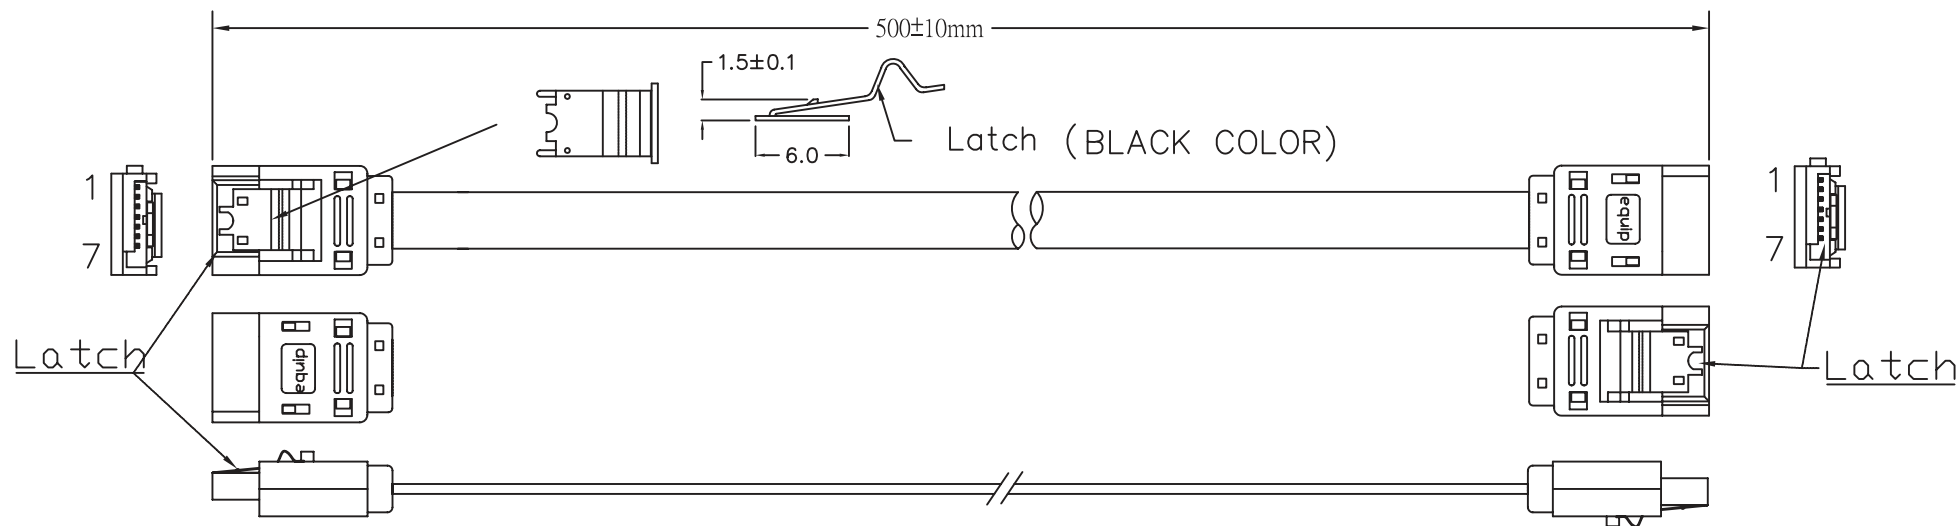

SERIAL ATA 7P(WITH Latch)
(ASS'Y BLACK COLOR)

SERIAL ATA 7P (WITH Latch)
(ASS'Y BLACK COLOR)

NOTE:

1. CABLE: 26AWG,UL2725,AL-FOIL,(26AWG*2C+AL)*2C+4D(28AWG),OD=2.3*8.3mm, RED COLOR(Pantone 200C),PVC JACKET.
2. LENGTH: 500mm.
3. CONNECTORS: SERIAL ATA 7P*2PCS(BLACK INSULATION,With metal Latch).
4. MOLD: ASSEMBLING TYPE(180°)--TYPE(180°)
5. CONTACTS:

SERIAL ATA 7P	1+4+7	2	3	5	6
SERIAL ATA 7P	1+4+7	2	3	5	6
6. OPEN/SHORT TEST: 100% TEST.
INSULATION: MIN. 2M.
7. PACKING: E'pui ZIP BAG

ITEM NO	Color	Length
111900	Red	500±10mm
111901	Red	1000±20mm

COMPANY	DDC		ITEM NO.		NO	B			SCALE	NON		
REVISION	DATE	DISCRIPTION	DRAWN BY						UNIT<mm>			
			DESIGNED BY						DRAWING NO.			
			APPROVAL BY									