



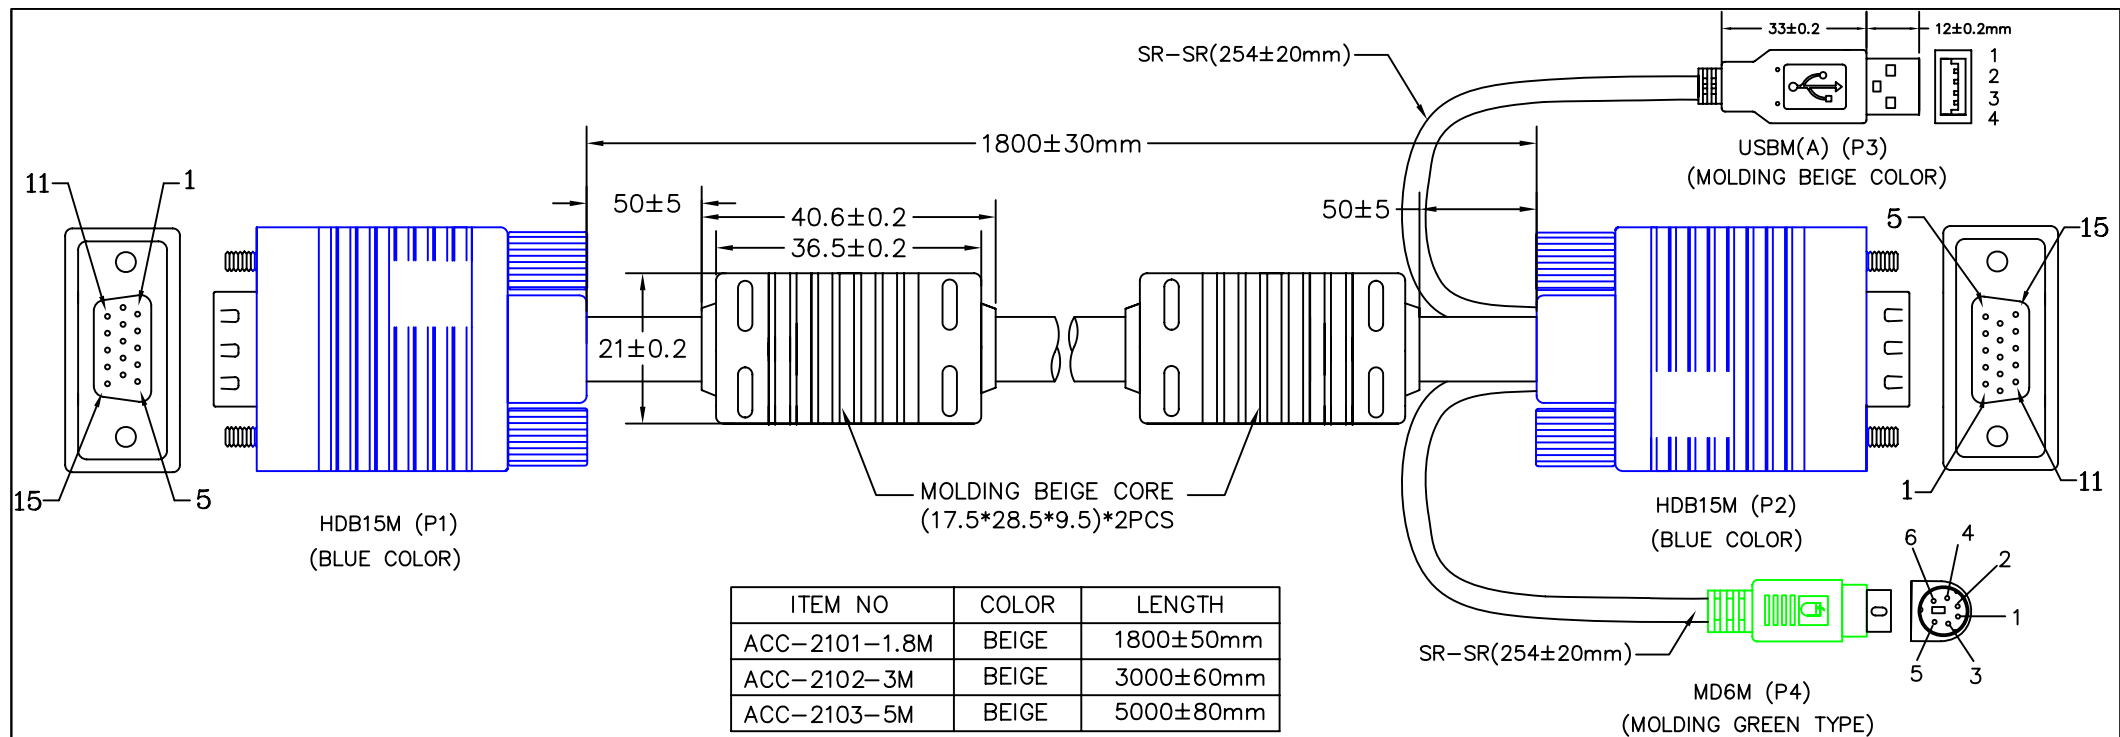

NOTE:

- CABLE: (A)28AWG(7/0.12TC),UL2919,AL+D+B(85% AL/MY)-FOIL,(28AWG\*1C+S)\*3COAX+28AWG\*9C,OD=8.5±0.2mm.BEIGE WITH EMBOSS,PVC JACKET[Conductor: TS].  
(B)UL2464,AL-FOIL,28AWG\*4C+D,OD=4.0mm,BEIGE COLOR,PVC JACKET
- LENGTH:1880mm.
- CONNECTORS:HDB15P\*2PCS(BLUE INSULATION)(FULL PIN G/F)(SHELL NICKEL).  
MD6M\*1PCS(GREEN INSULATION)(PING G/F)(SHELL NICKEL),  
USBAM\*1PCS(WHITE COLOR)(PIN G/F)(SHELL NICKEL).
- SCREW :INCH SCREW\*4,(BNC SCREW)(NICKEL),
- CONTACTS:

| P1 | 1 | 2 | 3 | 4 | 5    | 6    | 7   | 8   | 9 | 10 | 11 | 12 | 13 | 14 | 15 | 64    |
|----|---|---|---|---|------|------|-----|-----|---|----|----|----|----|----|----|-------|
| P2 | 1 | 2 | 3 |   |      | 5+10 | 7+8 | 7+8 |   |    |    | 12 | 13 | 14 | 15 | 64    |
| P3 |   |   |   | 2 | 3    | 4    |     |     |   | 1  |    |    |    |    |    | 64    |
| P4 | R | C | B | C | C    |      |     |     |   |    |    |    |    |    |    | 64    |
|    |   |   |   |   | Pair | R    | G   | G   | G | B  | G  |    |    |    |    | SHELL |
- MOLD: ASS'Y IBM TYPE.
- Test machine test condition.  
A.100% OPEN,SHORT&INTERMITANCE TEST.  
B.CONDUCTOR RESISTANCE: 3ohms MAX:  
C.INSULATION RESISTANCE: 5M Min/,10ms:
- ALL MUST BE RoHS COMPLIANT.

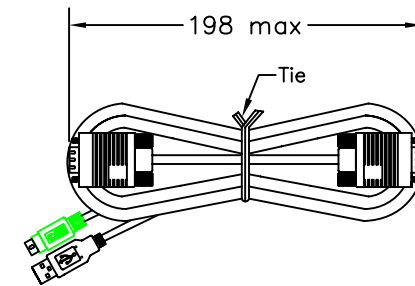

PACKING:1PCS/PE BAG+ITEM NO LABEL.

|          |            |             |             |               |      |   |           |                     |          |     |
|----------|------------|-------------|-------------|---------------|------|---|-----------|---------------------|----------|-----|
| COMPANY  | DDC        |             | ITEM NO.    | ACC-2101-1.8M | NO   | B | Part Name | HDB15MM-IBM 3COA+9C |          |     |
| REVISION | DATE       | DISCRIPTION | DRAWN BY    |               | SPEC |   |           |                     | SCALE    | NON |
| REV.A/0  | 2014.11.11 |             | DESIGNED BY |               |      |   |           |                     | UNIT(mm) |     |
|          |            |             | APPROVAL BY |               |      |   |           |                     | PAGE     | 1/1 |