



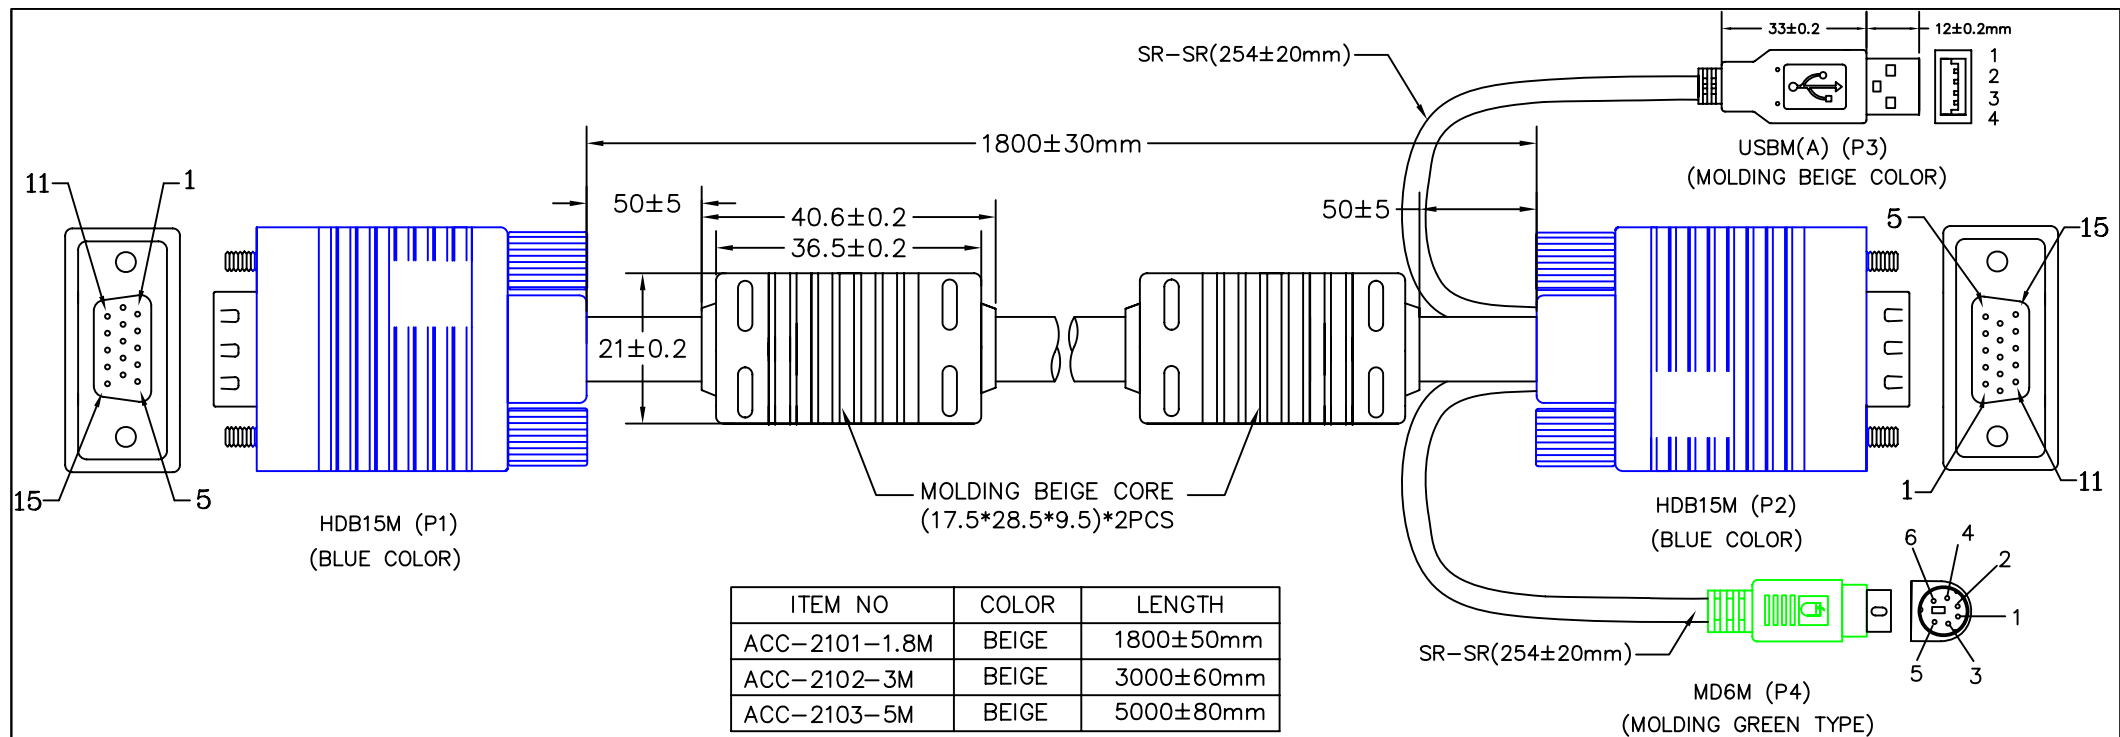

NOTE:

- CABLE: (A)28AWG(7/0.12TC),UL2919,AL+D+B(85% AL/MY)-FOIL,(28AWG*1C+S)*3COAX+28AWG*9C,OD=8.5±0.2mm.BEIGE WITH EMBOSS,PVC JACKET[Conductor: TS].
(B)UL2464,AL-FOIL,28AWG*4C+D,OD=4.0mm,BEIGE COLOR,PVC JACKET
 - LENGTH:1880mm.
 - CONNECTORS:HDB15P*2PCS(BLUE INSULATION)(FULL PIN G/F)(SHELL NICKEL).
MD6M*1PCS(GREEN INSULATION)(PING G/F)(SHELL NICKEL),
USBAM*1PCS(WHITE COLOR)(PIN G/F)(SHELL NICKEL).
 - SCREW :INCH SCREW*4,(BNC SCREW)(NICKEL),
 - CONTACTS:
- | P1 | 1 | 2 | 3 | 4 | 5 | 6 | 7 | 8 | 9 | 10 | 11 | 12 | 13 | 14 | 15 | 64 |
|----|---|---|---|------|---|------|-----|-----|---|----|----|----|----|----|----|-------|
| P2 | 1 | 2 | 3 | | | 5+10 | 7+8 | 7+8 | | | | 12 | 13 | 14 | 15 | 64 |
| P3 | | | | 2 | 3 | 4 | | | | 1 | | | | | | 64 |
| P4 | R | C | B | C | C | | | | | | | | | | | 64 |
| | | | | Pair | | R | G | G | G | B | G | | | | | SHELL |
- MOLD: ASS'Y IBM TYPE.
 - Test machine test condition.
A.100% OPEN,SHORT&INTERMITANCE TEST.
B.CONDUCTOR RESISTANCE: 3ohms MAX:
C.INSULATION RESISTANCE: 5M Min/,10ms:
 - ALL MUST BE RoHS COMPLIANT.

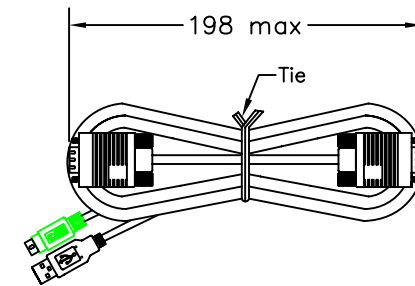

PACKING:1PCS/PE BAG+ITEM NO LABEL.

COMPANY	DDC		ITEM NO.	ACC-2101-1.8M	NO	B	Part Name	HDB15MM-IBM 3COA+9C		
REVISION	DATE	DISCRIPTION	DRAWN BY		SPEC				SCALE	NON
REV.A/0	2014.11.11		DESIGNED BY						UNIT(mm)	
			APPROVAL BY						PAGE	1/1